

THE TAMESIDE METROPOLITAN BOROUGH COUNCIL

(SAMUEL STREET, HOLLINGWORTH )

(PROHIBITION OF DRIVING) ORDER 1988


THE TAMESIDE METROPOLITAN BOROUGH COUNCIL in exercise of its powers under Section 1(1) and (2), 2(1) to (3) and 4(2) of the Road Traffic Regulation Act 1984 ("the Act") and of all other enabling powers and after consultation with the Chief Officer of Police in accordance with Schedule 9 of the Act of 1984 hereby makes the following Order:-

1. No person shall cause or permit any vehicle to proceed in that length of that length of Samuel Street, Hollingworth from its junction with Woolley Lane for a distance of 2 metres in a North Easterly direction.
2. This Order shall come into operation on the <sup>11<sup>th</sup></sup> day of ~~APRIL~~ APRIL 1988. and may be cited as "The Tameside Metropolitan Borough Council (Samuel Street, Hollingworth) (Prohibition of Driving) Order 1988.

GIVEN UNDER THE COMMON  
SEAL OF THE TAMESIDE  
METROPOLITAN BOROUGH COUNCIL  
on the ~~8<sup>th</sup>~~ day of ~~APRIL~~  
1988

*D. N. Keating*


DIRECTOR OF POLICY SERVICES

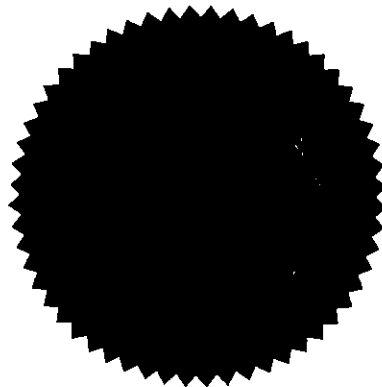

57517

LO 24

# Longendale Secondary and Hollingworth County Primary Schools

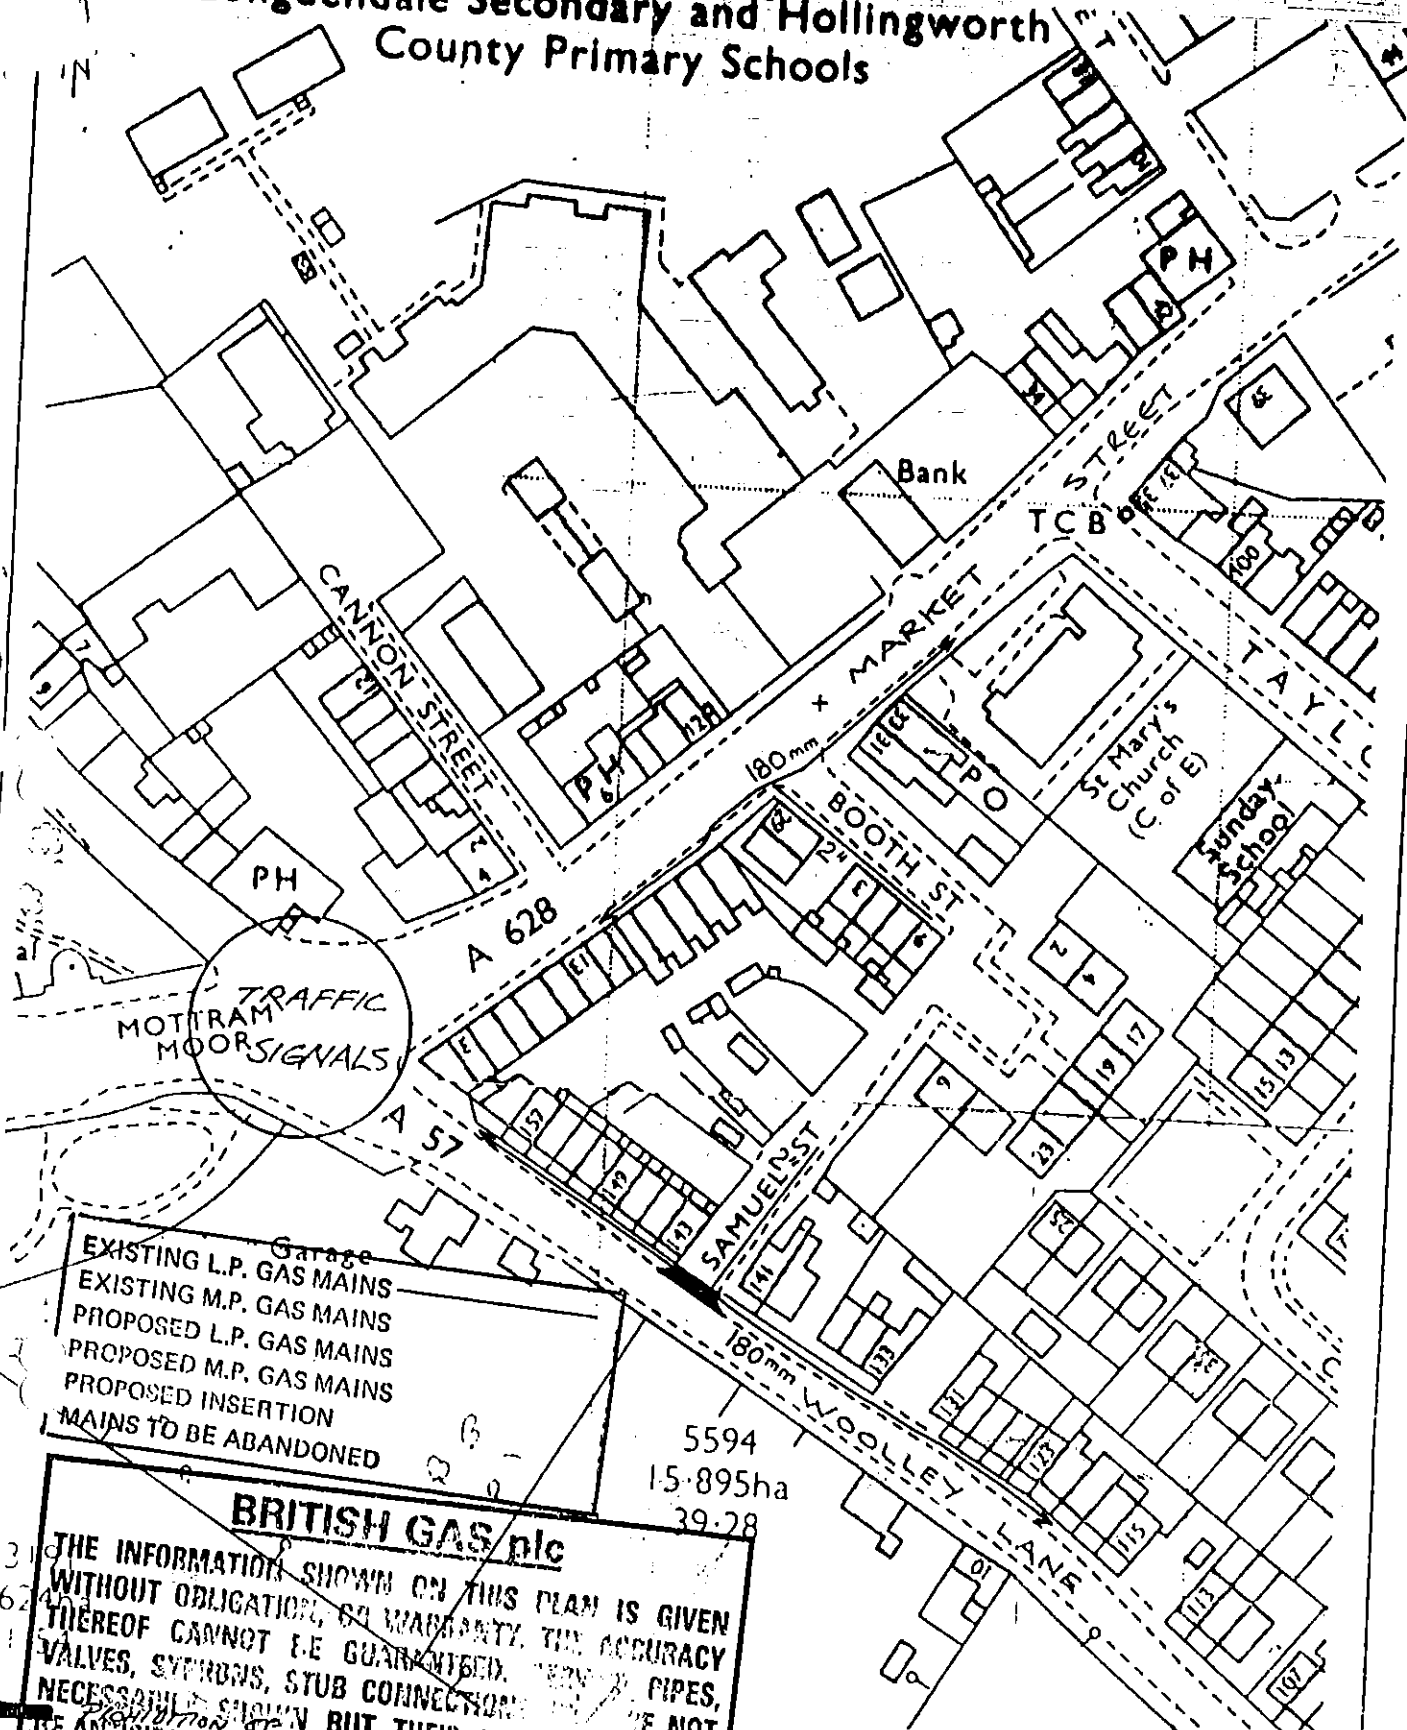

Garage  
 EXISTING L.P. GAS MAINS  
 EXISTING M.P. GAS MAINS  
 PROPOSED L.P. GAS MAINS  
 PROPOSED M.P. GAS MAINS  
 PROPOSED INSERTION  
 MAINS TO BE ABANDONED

5594  
 15.895ha  
 39.28

## BRITISH GAS plc

THE INFORMATION SHOWN ON THIS PLAN IS GIVEN WITHOUT OBLIGATION, SO WARRANTY, THE ACCURACY THEREOF CANNOT BE GUARANTEED. VALVES, SYMBOIS, STUB CONNECTIONS NECESSARILY SHOWN BUT THEIR POSITIONS SHOULD BE CHECKED. NO LIABILITY OF ANY KIND IS ACCEPTED BY BRITISH GAS plc FOR ANY ERROR OR OMISSION IN THE POSITION OF MAINS ALSO SET OUT AND ESTABLISHED ON SITE BEFORE THE PLANT IS USED.

TITLE: PROPOSED L.P. GAS MAINS  
 OF DRINKING WATER  
 SAMUEL STREET  
 HOUGHTON  
 PROPOSALS


Drn. BG  
 Trd.  
 Cndd.  
 Date: 7/87 Scale 1:1250  
 Dwg no TA/1074/2

EXISTING L.P. GAS MAINS  
 EXISTING M.P. GAS MAINS  
 PROPOSED L.P. GAS MAINS  
 PROPOSED M.P. GAS MAINS  
 PROPOSED INSERTION  
 MAINS TO BE ABANDONED

Tel no 061 330 07

**Jarneside M.B.C. ENGINEERS**

# Longdendale Secondary and Hollingworth County Primary Schools

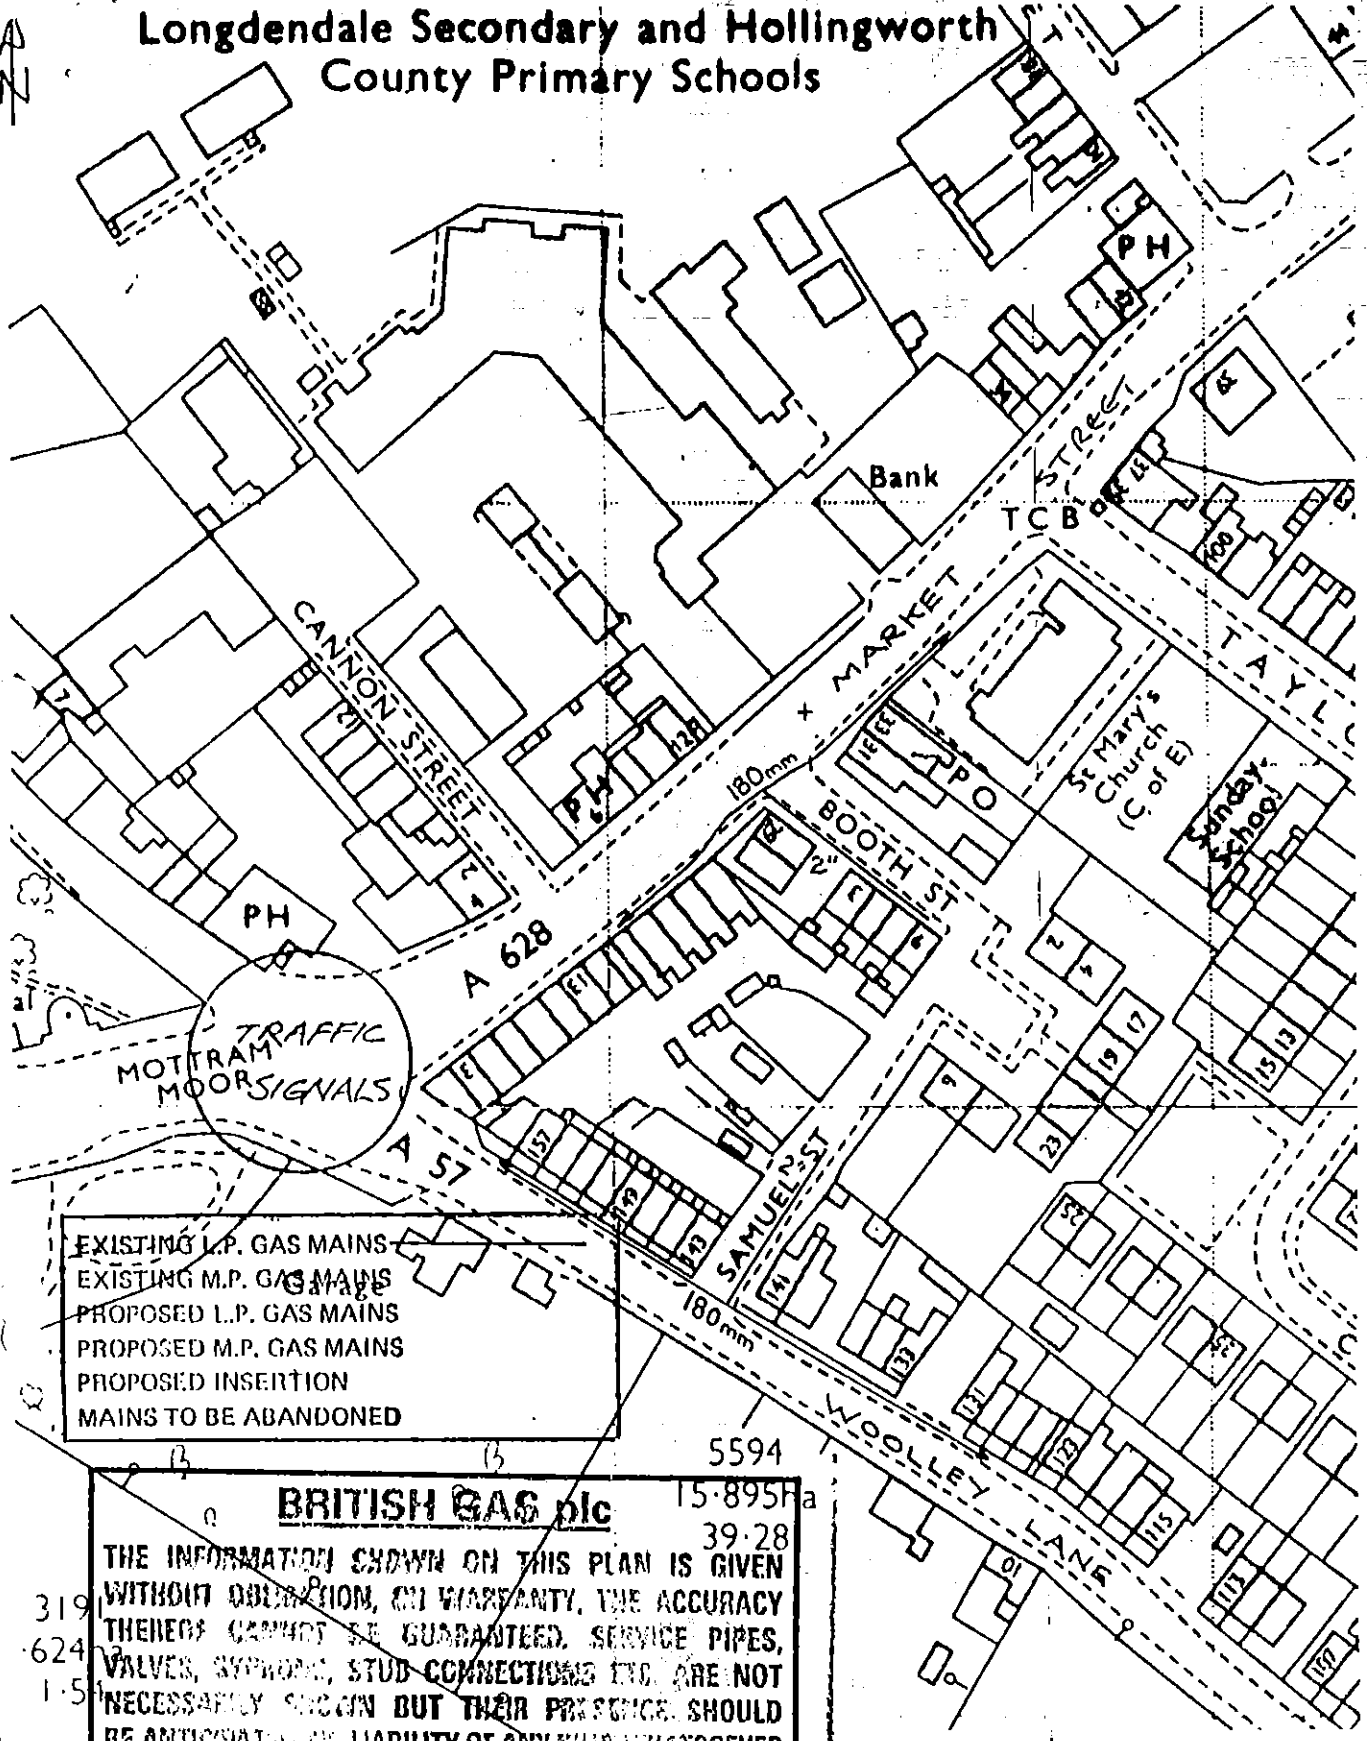


EXISTING L.P. GAS MAINS  
 EXISTING M.P. GAS MAINS  
 PROPOSED L.P. GAS MAINS  
 PROPOSED M.P. GAS MAINS  
 PROPOSED INSERTION  
 MAINS TO BE ABANDONED

**BRITISH GAS plc** 15-8951 a  
 39-28  
 THE INFORMATION SHOWN ON THIS PLAN IS GIVEN WITHOUT OBLIGATION, OR WARRANTY, THE ACCURACY THEREOF CANNOT BE GUARANTEED. SERVICE PIPES, VALVES, SYPHONS, STUD CONNECTIONS ETC. ARE NOT NECESSARILY SHOWN BUT THEIR PRESENCE SHOULD BE ANTICIPATED. NO LIABILITY OF ANY KIND WHATSOEVER IS ACCEPTED BY BRITISH GAS plc, ITS AGENTS OR SERVANTS FOR ANY ERROR OR OMISSION. THE ACTUAL POSITION OF MAINS AND SERVICES MUST BE VERIFIED AND ESTABLISHED ON SITE BEFORE ANY MECHANICAL PLANT IS USED.

Dn. BG Date 7/87 Scale 1:1250  
 Trd. Dro no. 7A/1074/1  
 Chkd.

Civil Engineer  
 G.I. Baldwin, B.Eng. M.I.C.E. F.I.Mun.E.  
 Council Offices,  
 Wellington Rd.,  
 Ashton-u-Lyne OL8 8DL. Tel no 061.330.63'5


**Tameside M.B.C.  
ENGINEERS**

EXISTING